

**KA DESIGNS LLC**  
CONSULTING ENGINEER  
918 14TH STREET WEST  
BRADENTON FLORIDA 34205  
941-748-8611

**KA**  
ENGINEERING

CAD FILE NAME: \_\_\_\_\_  
DRAWN BY: MLC  
CHECKED BY: KAG  
JOB NO.: \_\_\_\_\_  
DATE: 24 SEP 07  
SHEET NO.: E6

ELECTRICAL  
DETAILS

APR 24 2008

KENNETH A. GONCI  
P.E. - 61685  
Approved by:


NEW MASJID  
SARASOTA, FL 34234-5561  
4350 LOCKWOOD RIDGE ROAD  
L.S.S.B.

OSBORN SHARP ASSOCIATES  
2477 Siskey Point Road - Suite 114A - Sarasota, Florida 34231  
TEL 941.922.5866 FAX 941.925.9820


Architecture Planning Energy Management AA-F000073

© Copyright 2006

PRAYER HALL LIGHTING RISER  
SCALE: NONE  
DIAGRAM

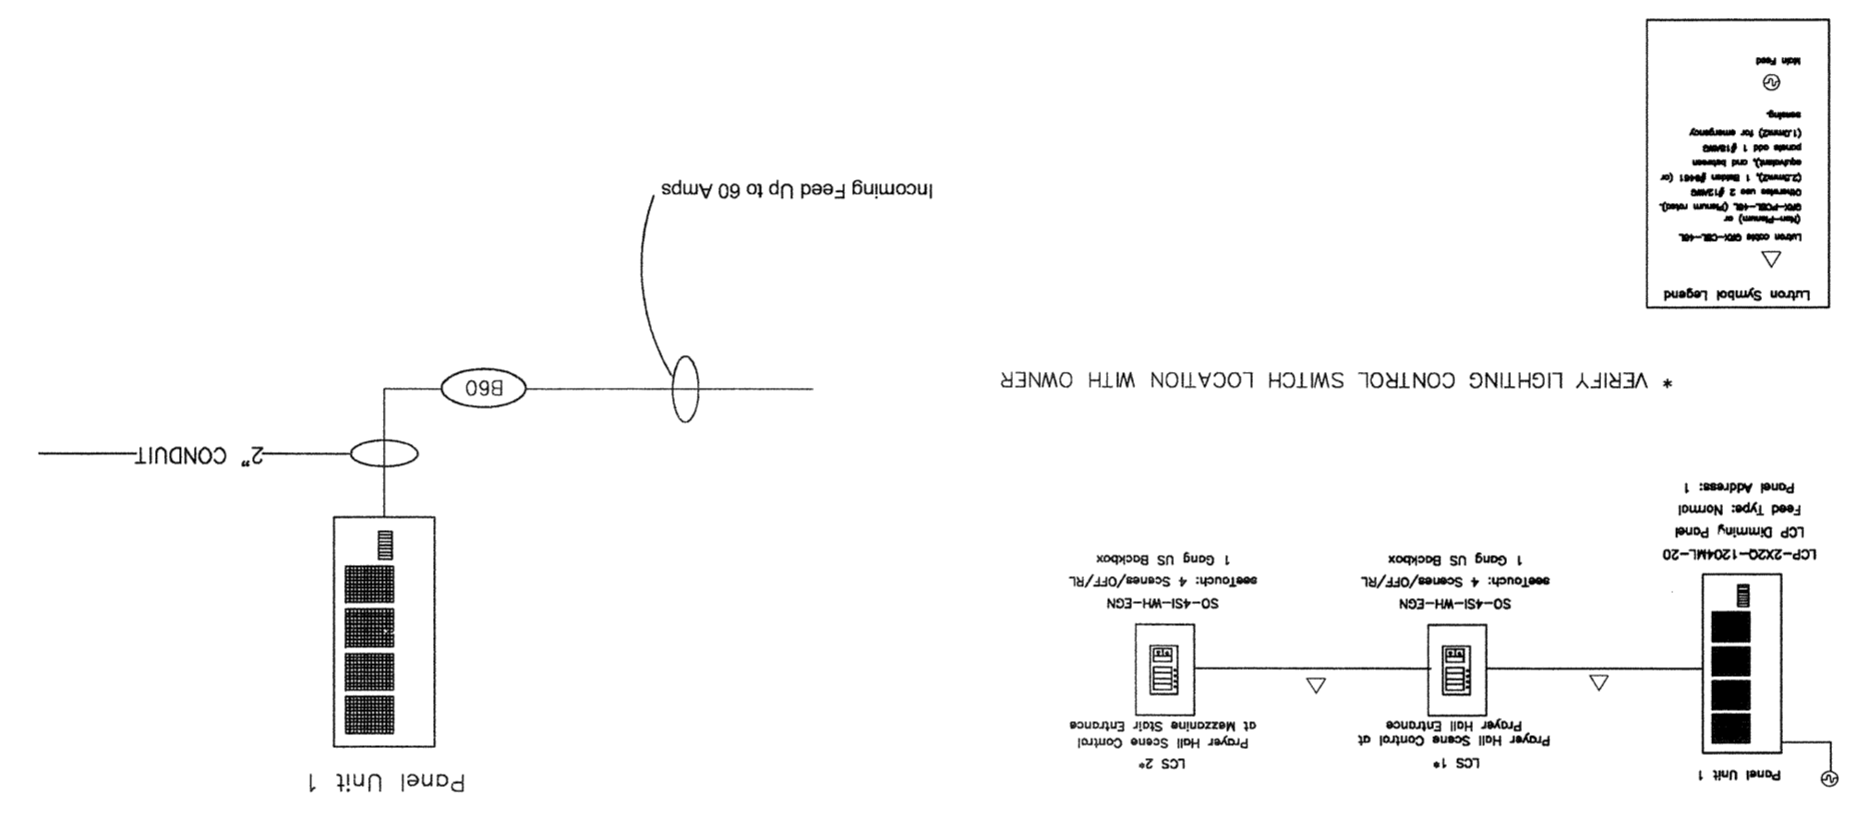

EXPOSED CONDUIT STUB-UP  
SCALE: NONE

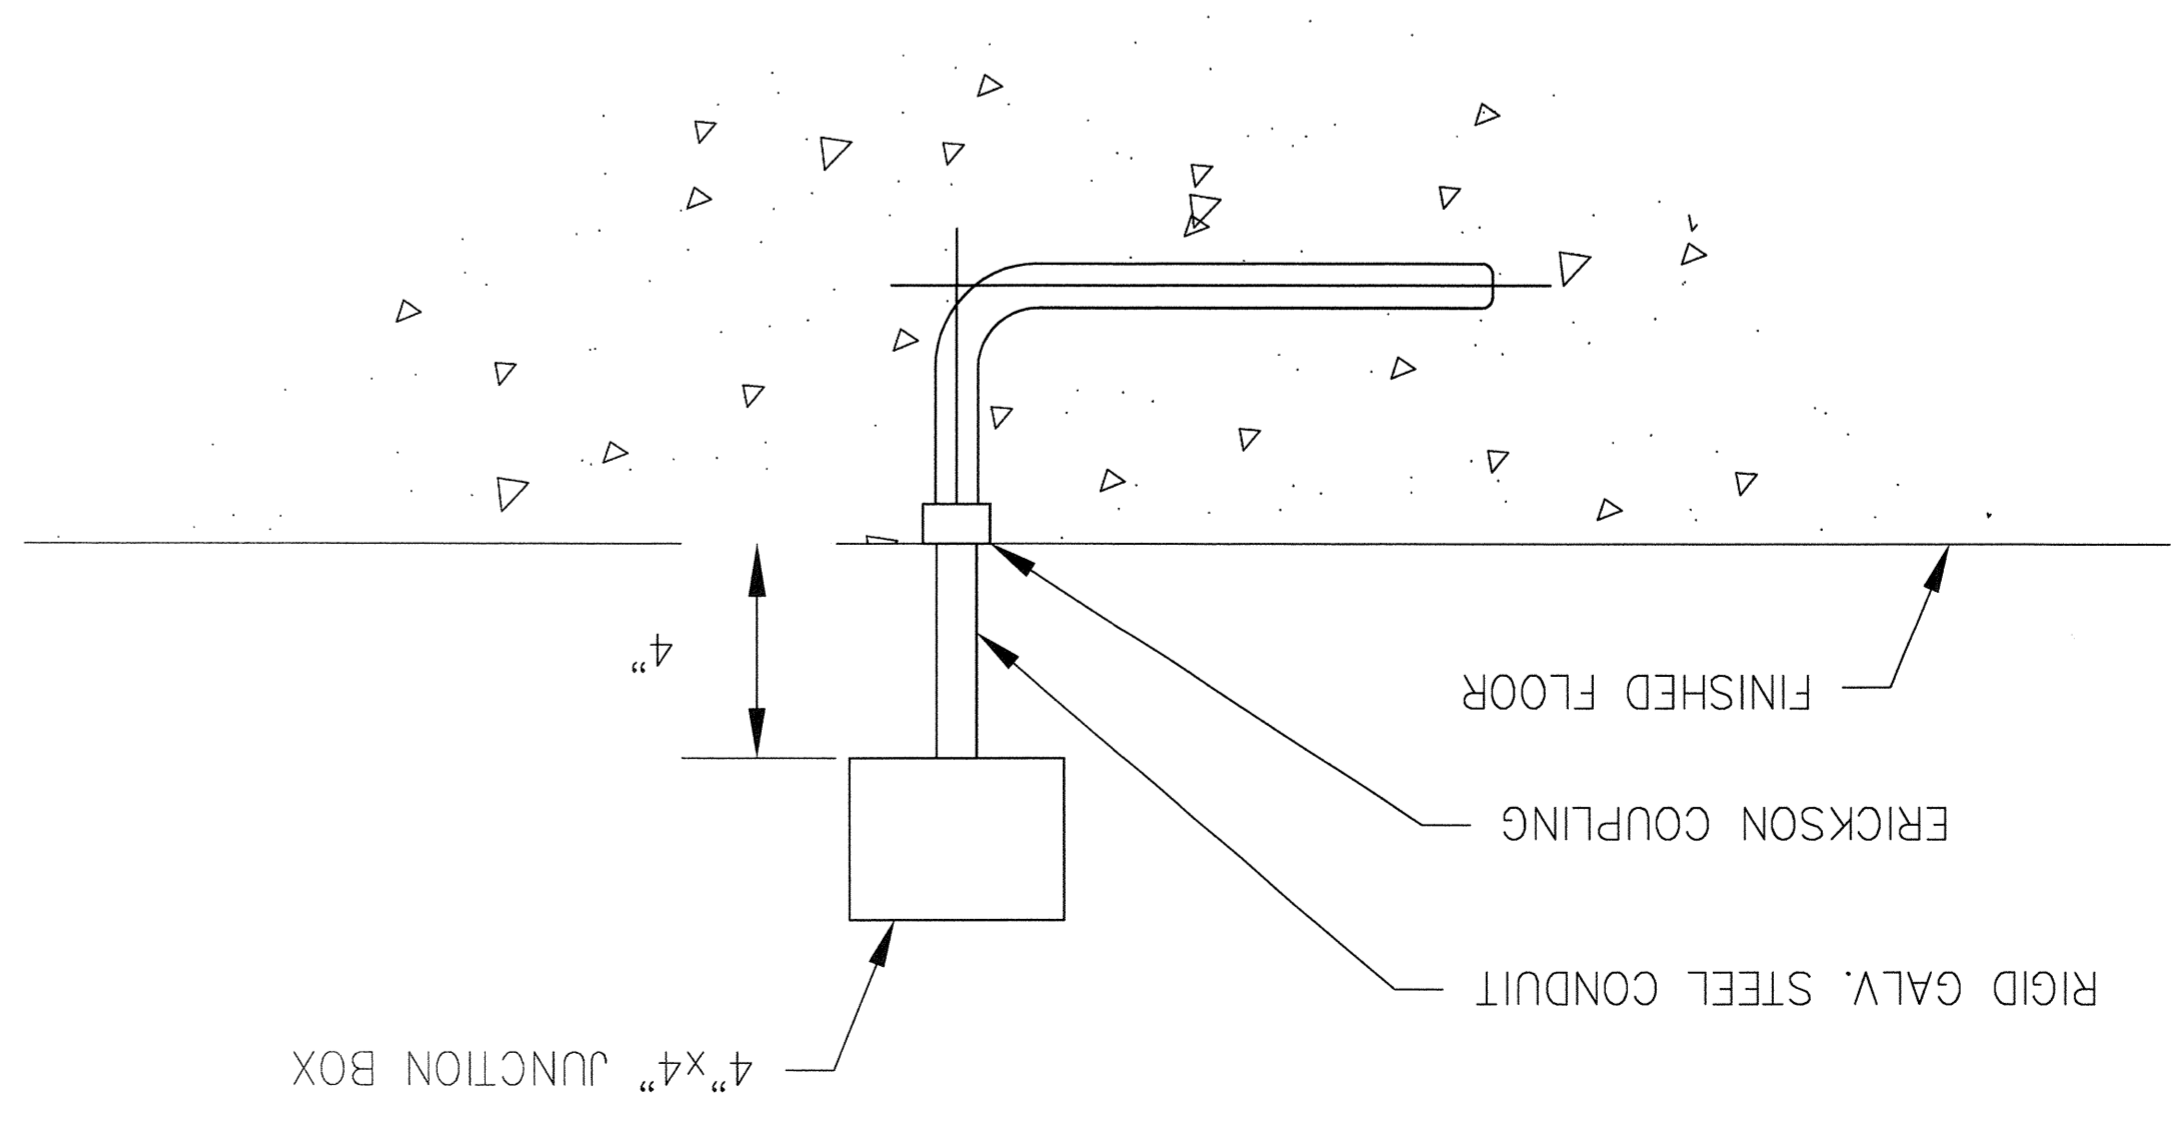

ELECTRICAL RISER  
SCALE: NONE

